


LEGEND

- XXX SWITCHBOARD
- CABLE/CONDUIT ROUTE - POWER
- B CABLE PIT - POWER
- FLOODLIGHT
- POLE

0 5000 10000 20000 30000
 Full Size 1:500; Half Reduction 1:1000
 SCALE (mm)

ALL DIMENSIONS ARE IN MILLIMETRES
 DRAWN IN ACCORDANCE WITH AS1100-1992
 DO NOT SCALE
 THIRD ANGLE PROJECTION

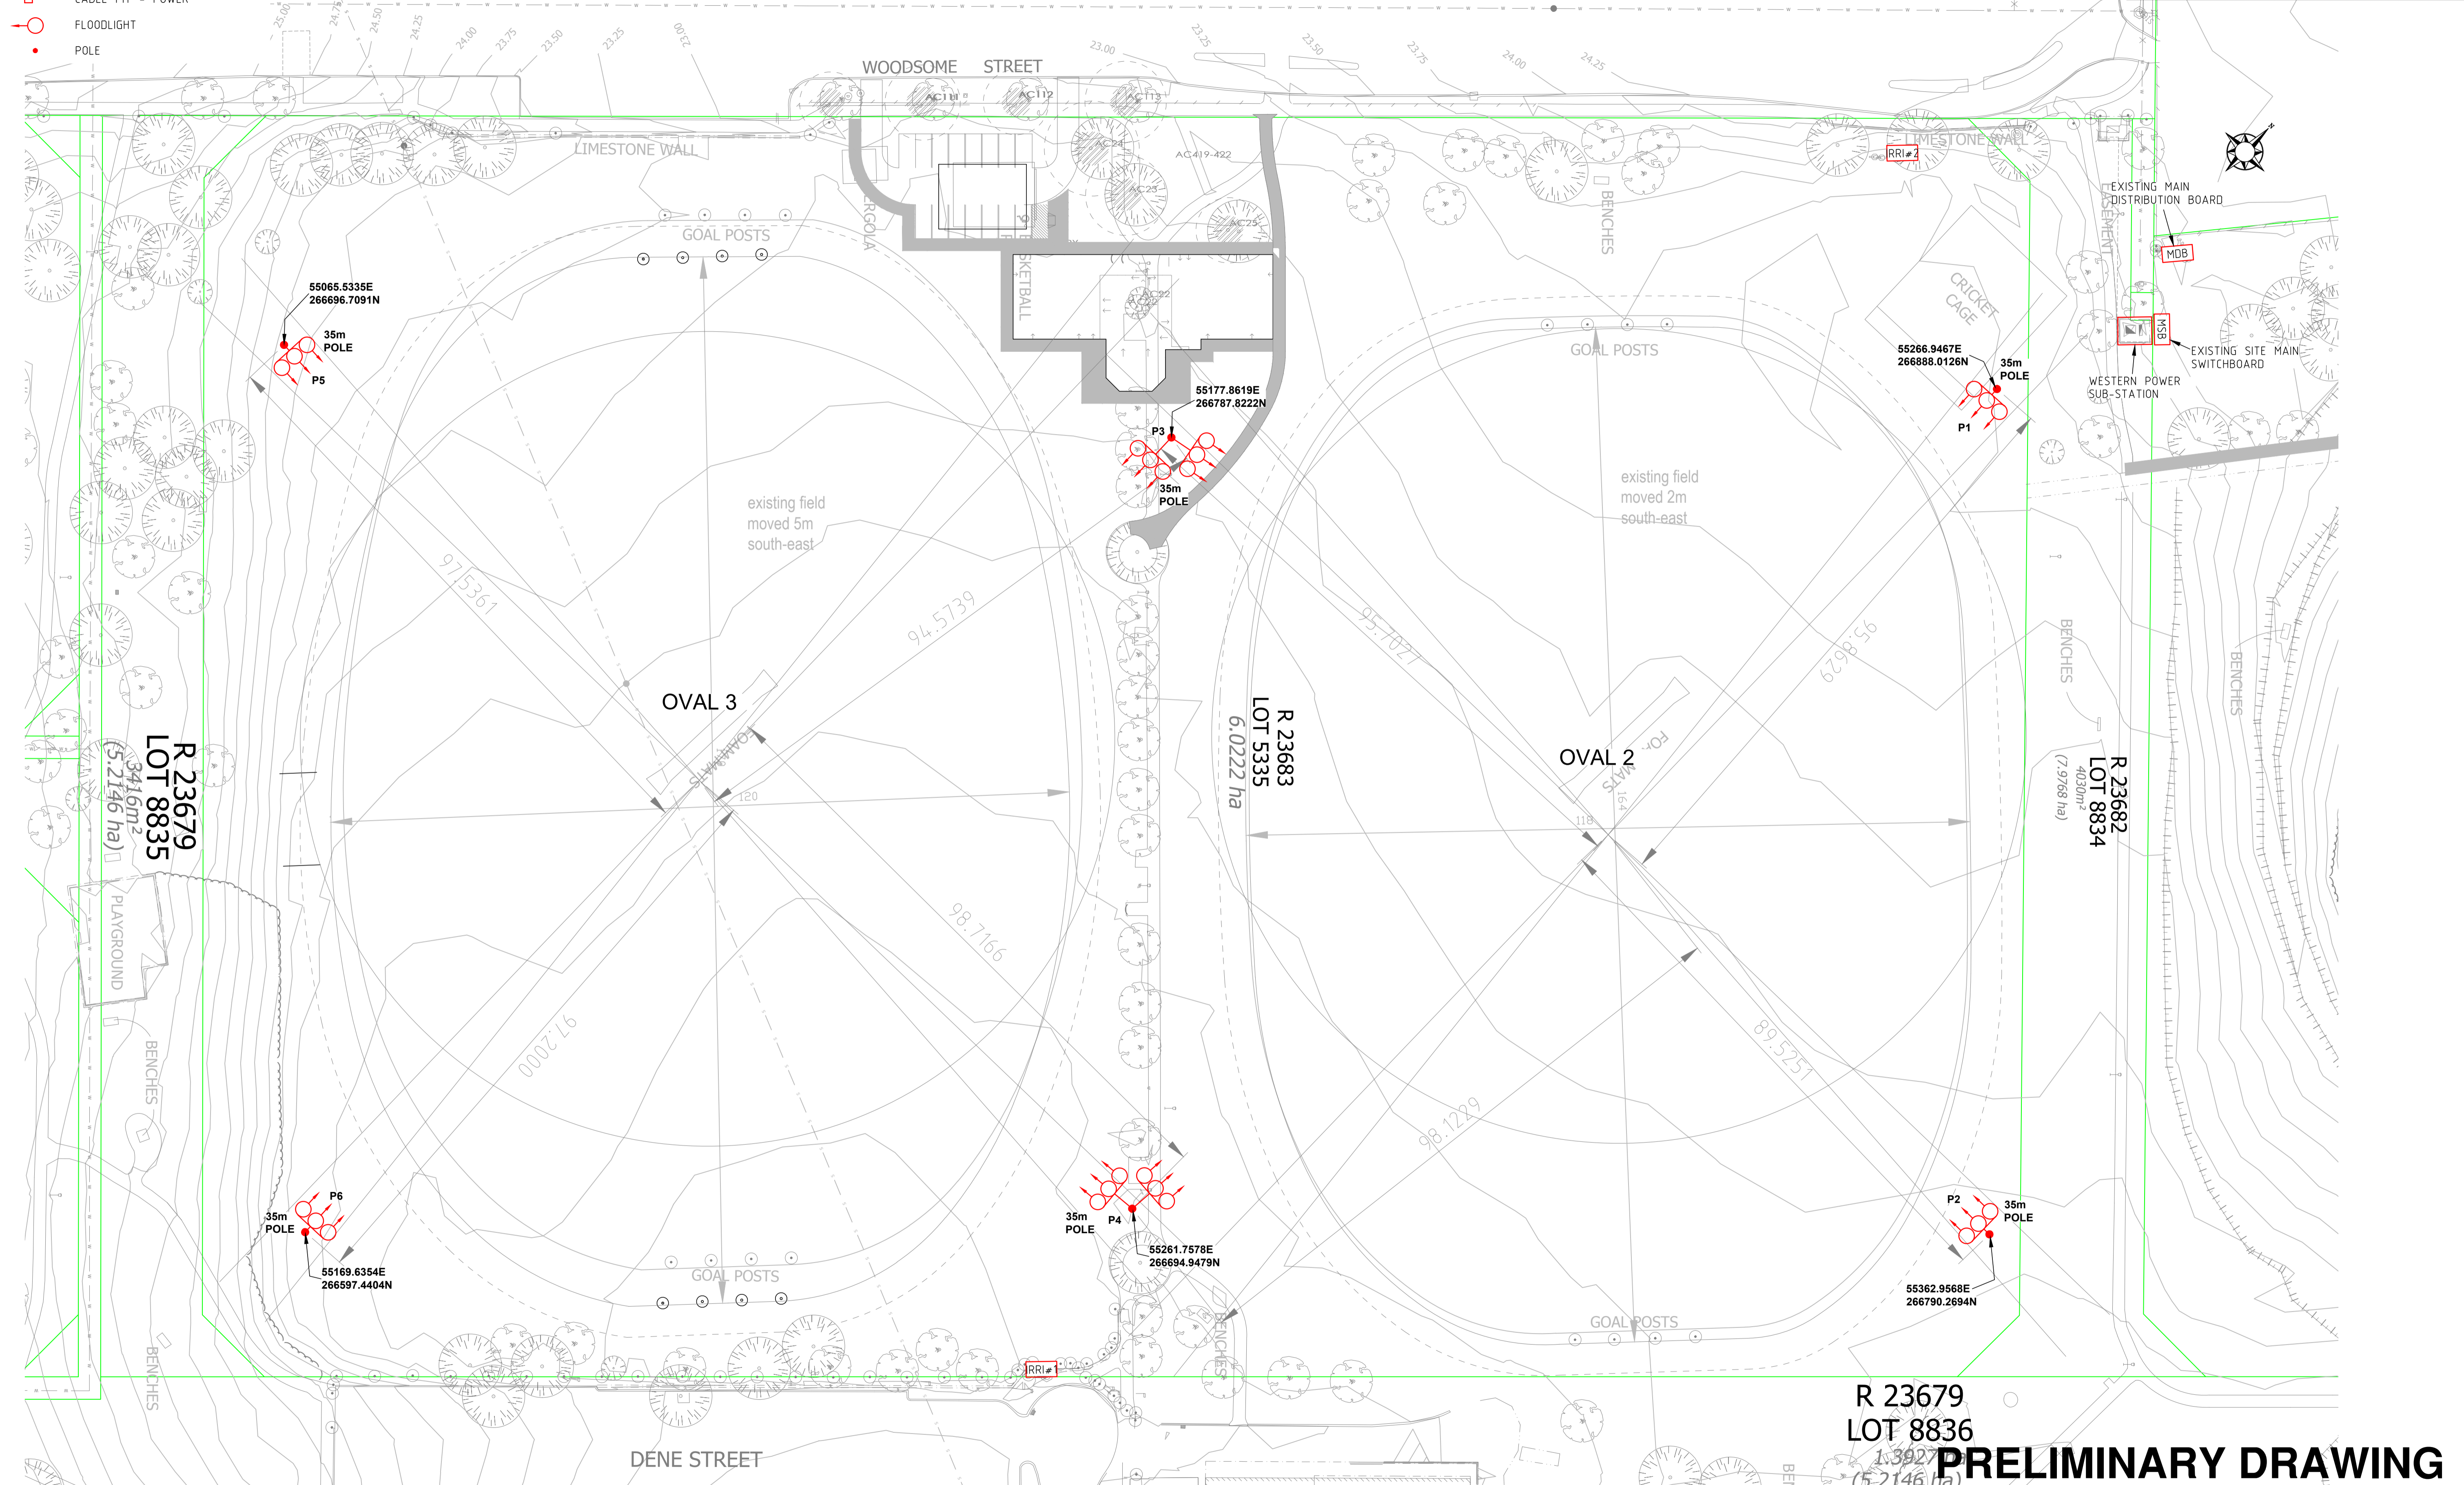

**R 23679
 LOT 8836
 (5,2146 ha)**
PRELIMINARY DRAWING

ISSUE	REVISION	DATE	CHECKED	ISSUE	REVISION	DATE	CHECKED
A1	A	5/3/2019	M.D.S.				

SAGE CONSULTING ENGINEERS Pty. Ltd.
 203 RAILWAY ROAD
 SUBIACO W.A. 6008
 TEL: (08) 9388 9745
 FAX: (08) 9388 9256
 Email: msage@inet.net.au
 A.C.N. 082 955 217

Copyright of this drawing is vested in: **SAGE CONSULTING ENGINEERS** and the contents are solely for the use of the client and Project identified on this drawing.



P.O. BOX 1533
 OSBORNE PARK W.A 6916
 TEL: (08) 9205 8555
 Fax: (08) 9345 8822
 Email: stirling@stirling.wa.gov.au

ELECTRICAL SERVICES
 CITY OF STIRLING SPORTS LIGHTING
 HAMER PARK INGLEWOOD
 OVALS 2 & 3 SITE PLAN

DESIGNED L.A.	DRAWN L.A.	CHECKED M.D.S.
DATE 27/02/19	SCALE 1:500 @A1	
AS/NZS ISO 9001:2008 Certificate No. 9000 254		PROJECT No. 2742
		DRAWING No. E5A
		SHEET # OF #